


RECEIVED
14 APR 2014

Project: 88 THE BROADWAY
WIMBLEDON, SW19 1RH
Drawing: PROPOSED GROUND FLOOR
PLAN
Number: 362-100-P
Date: 03.03.2014
Scale: 1:100@A3

BRIAN O'REILLY ARCHITECTS
11, C. ST. JOHN'S SQUARE, WIMBLEDON, MIDDLESEX, TW20 1JL
Tel: +44 (0)20 7287 1184
www.brianoreillyarchitects.com
mailto:brianoreillyarchitects.com

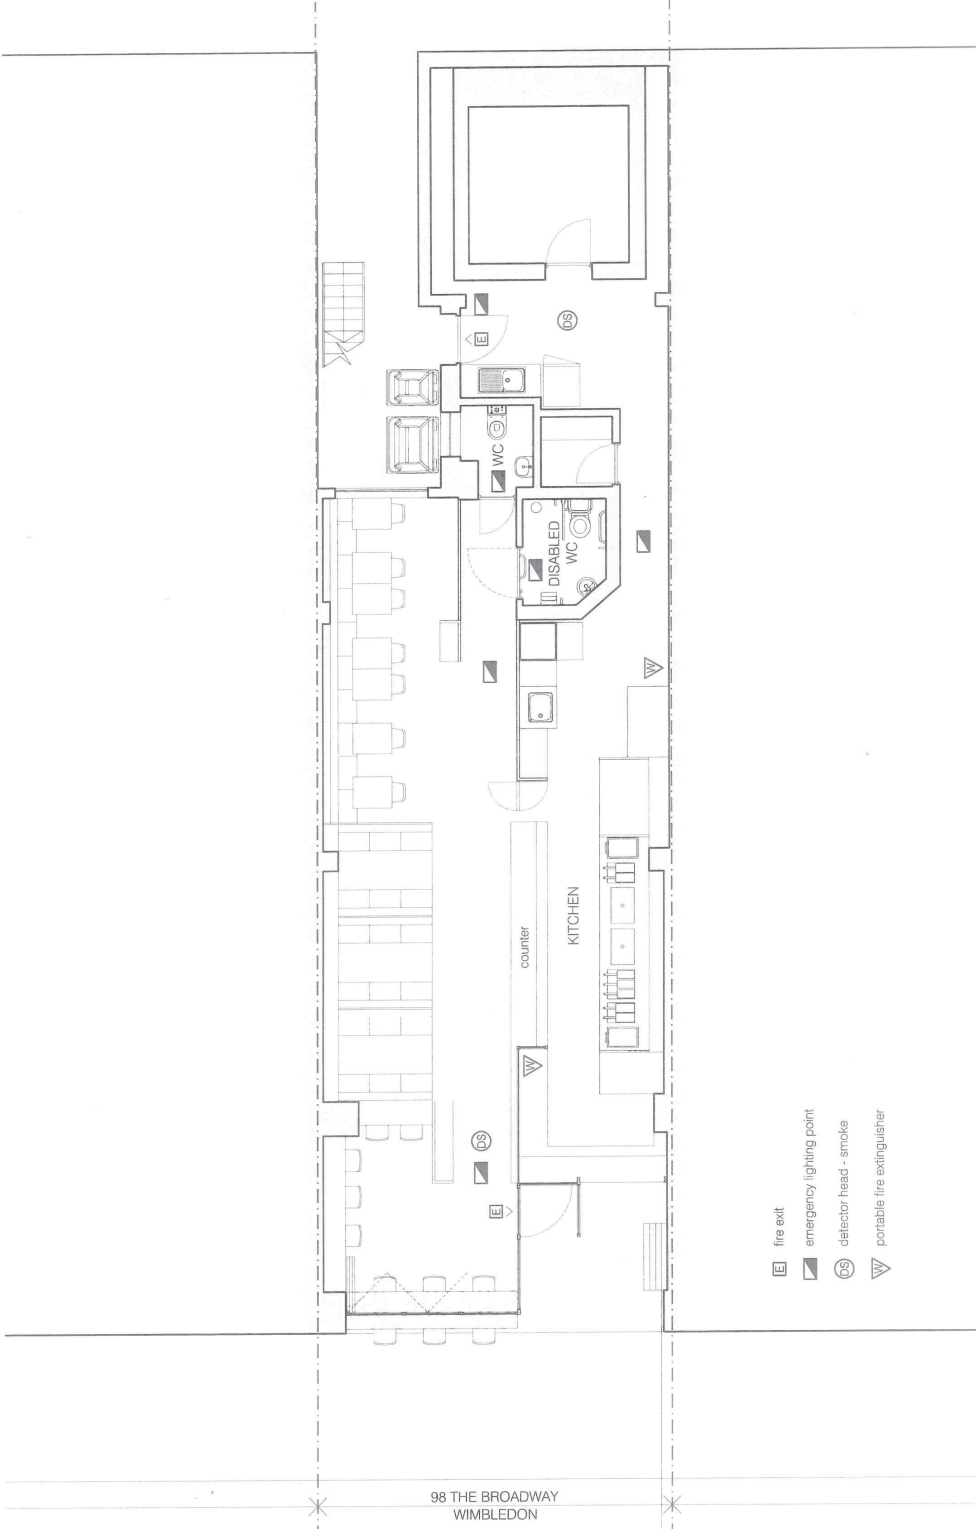

- E fire exit
- emergency lighting point
- CS detector head - smoke
- V portable fire extinguisher



PROPOSED GROUND FLOOR PLAN
scale 1:50

This page is intentionally left blank